



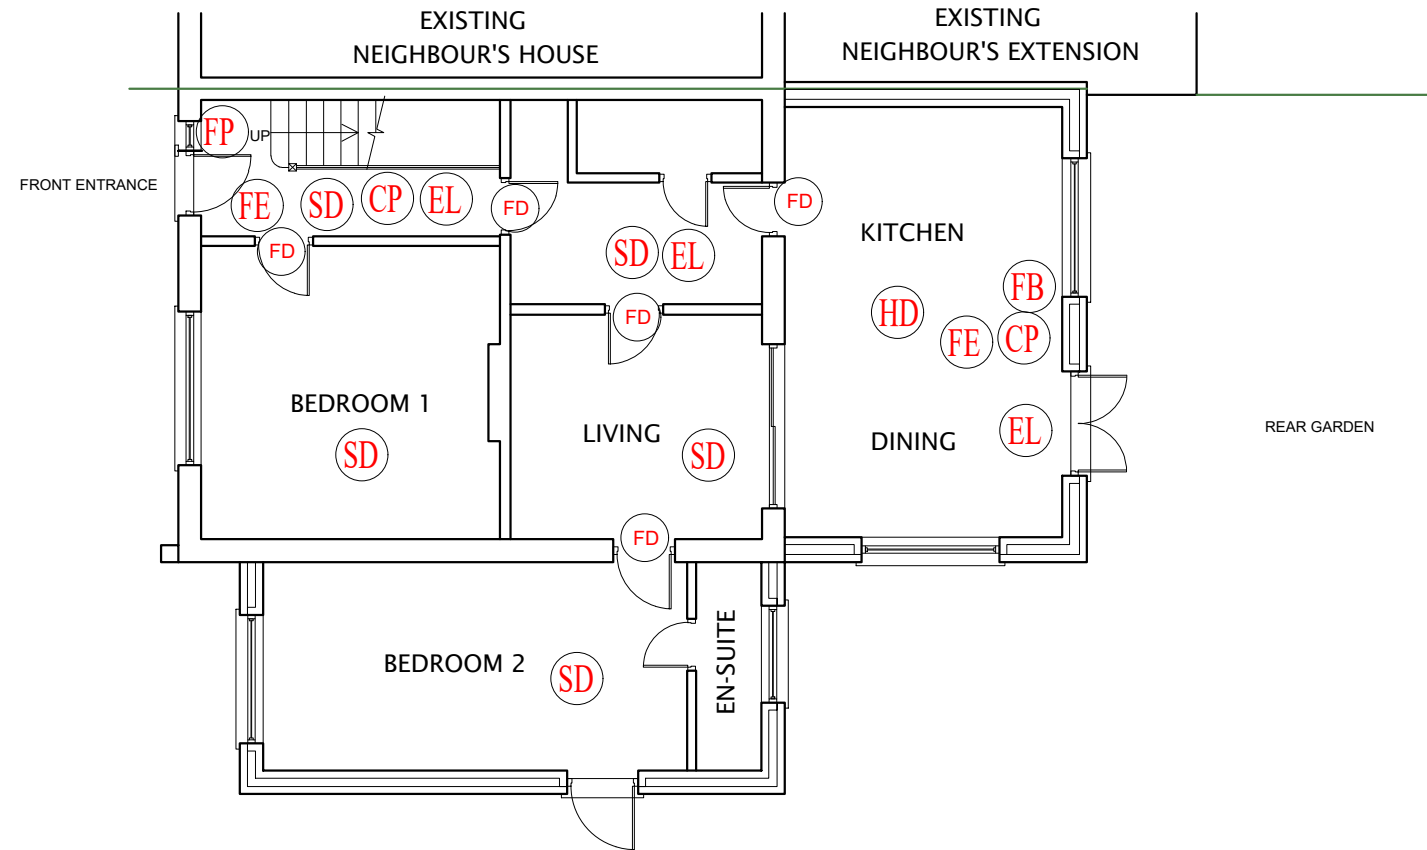

GROUND FLOOR PLAN

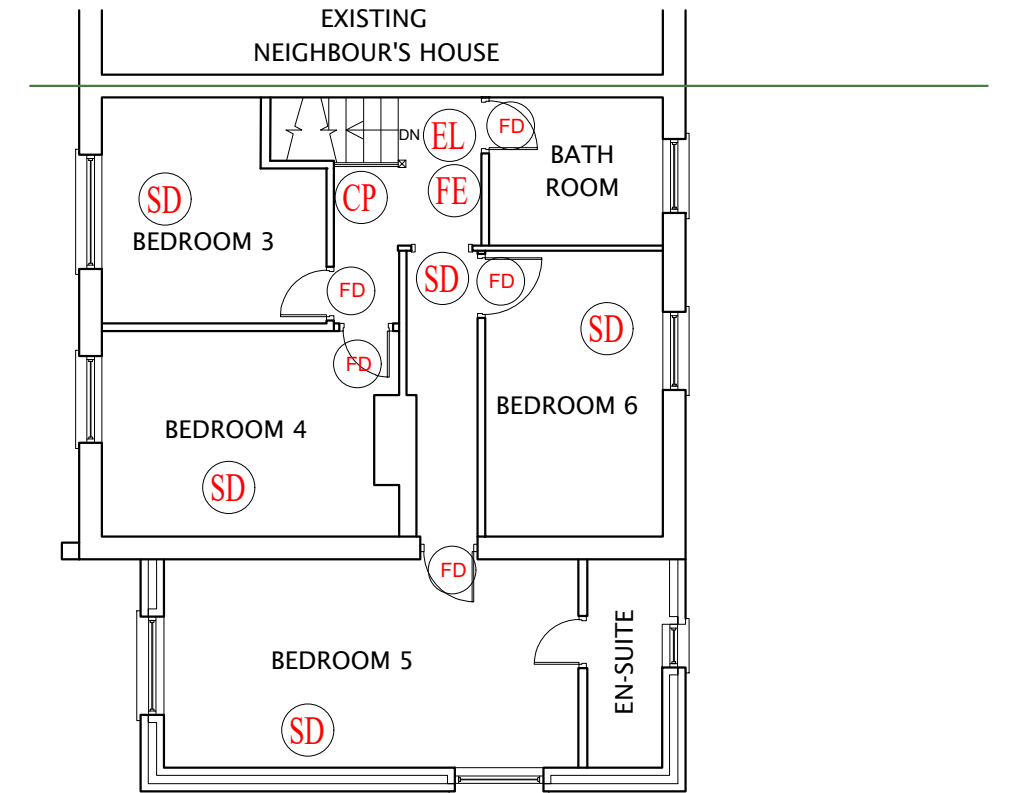

FIRST FLOOR PLAN

FIRE LARM SYSTEM EACH FLAT TO BS5446	
CP	Call Point.
SD	Smoke Detector
FB	Fire Blanket
FP	Fire Panel
HD	Heat Detector
FE	Fire Extinguisher

EMERGENCY ALARM SYSTEM TO BS5226	
EL	Emergency Lighting
FD	Fire Door



Scale 1:100

© SA DESIGN AND MANAGEMENT moshamaun@hotmail.co.uk /saud_ahmad67@hotmail.com Tel: 078598 77288				
Client	Mr Avtar Singh Gohlan	Site	10 SHANNON CLOSE, SOUTHALL, MIDDX , UB2 5SX	
Project	HMO Drawing	Title	BLOCK PLAN	
Scale	1:00 @ A3	Date	03/05/2022	Revision
		Drawn by	MS	1
		Drg. No	10S/PLN	